


**NOTES**

- 1) THIS DRAWING IS INDICATIVE FOR TENDER PURPOSE ONLY.
- 2) BAY ARRANGEMENT SHALL BE FINALIZED DURING EXECUTION STAGE.
- 3) NUMBER OF SECONDARY CORE & WINDINGS OF CT & VT WILL BE AS PER DETAIL ENGINEERING.
- 4) THIS DRAWING IS ISSUED FOR BIDDING PURPOSE.

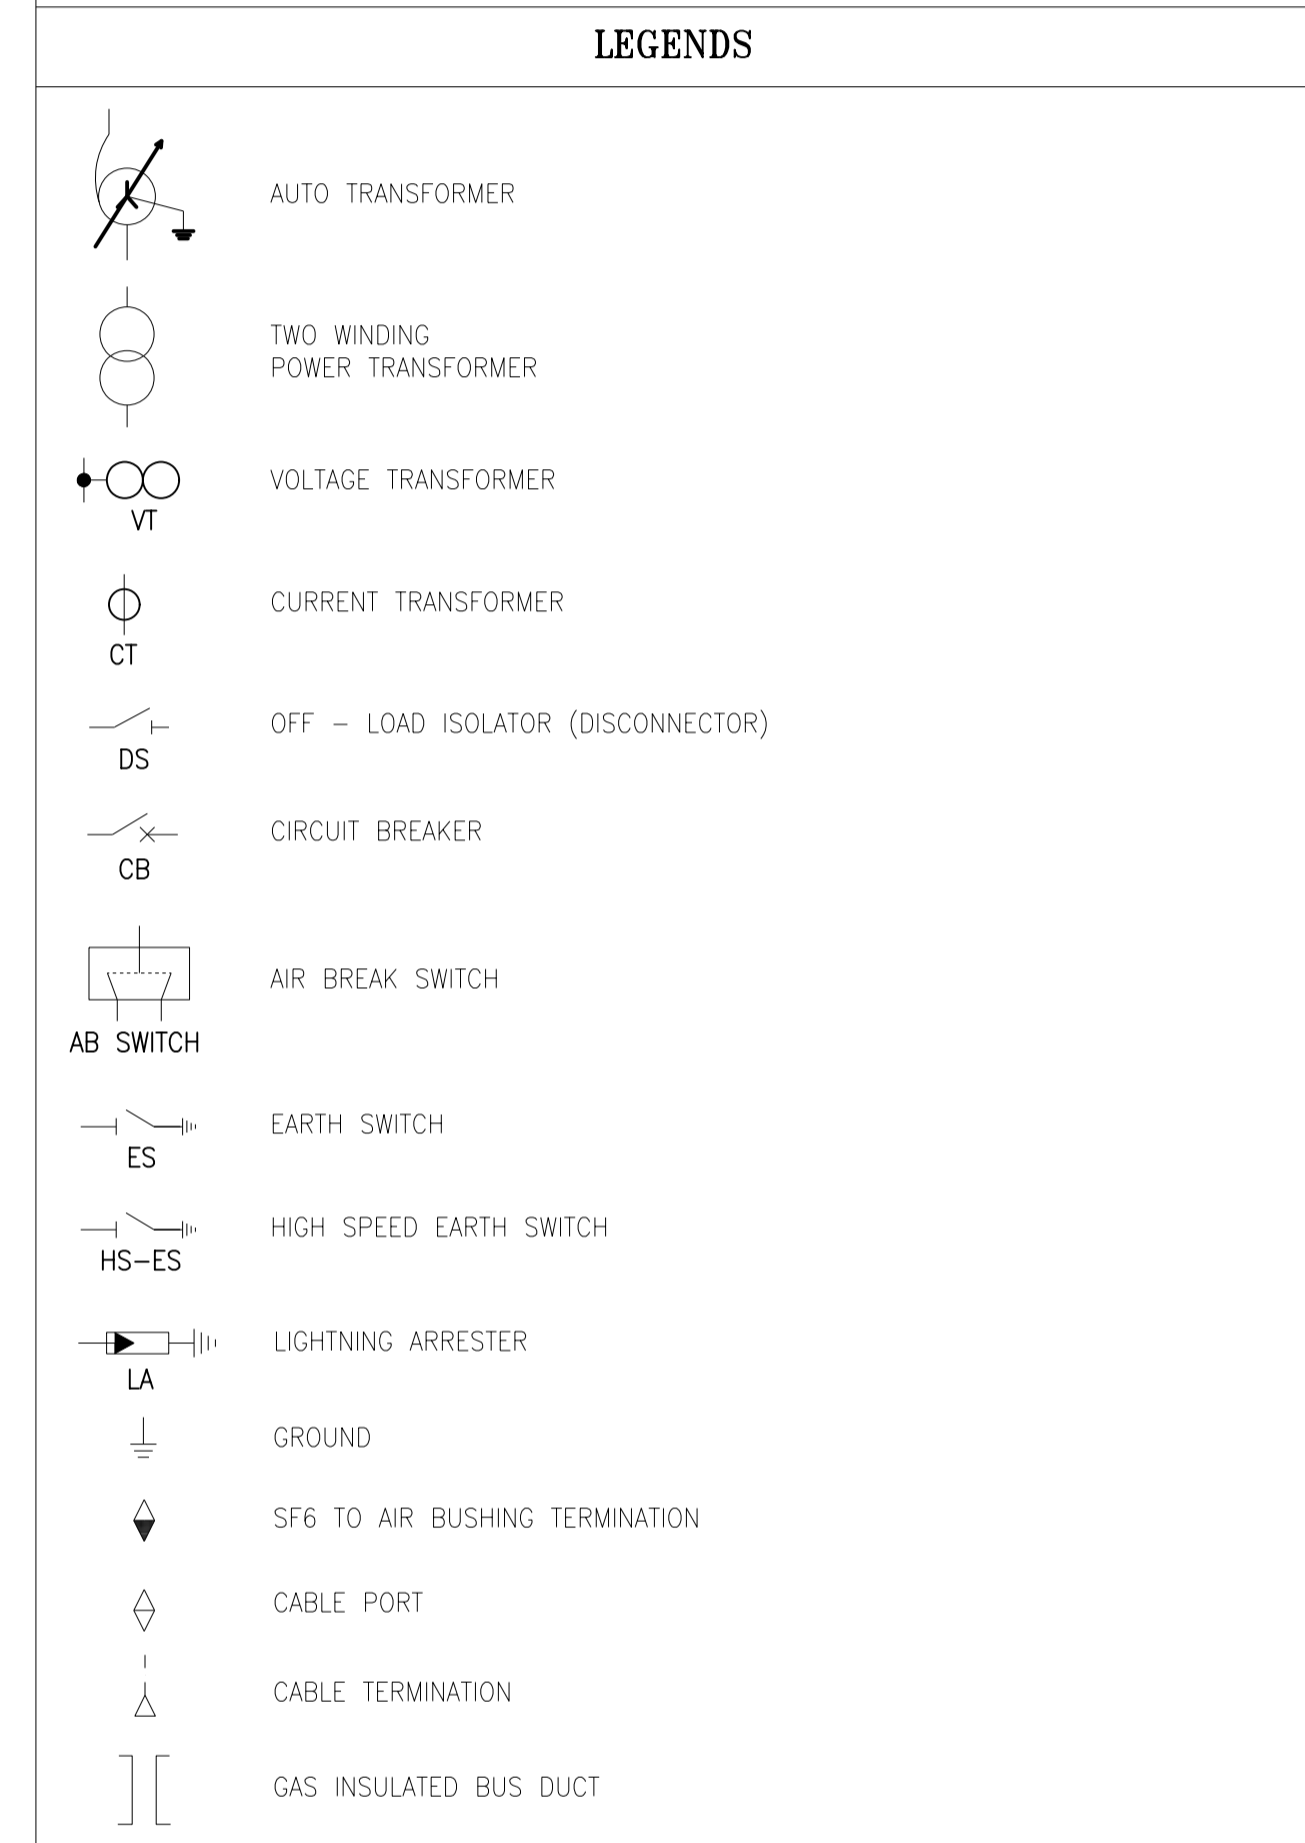

FOR BIDDING PURPOSE ONLY

Project: <b>ID-P245 ODISHA TRANSMISSION SYSTEM IMPROVEMENT PROJECT PACKAGE-3A</b>			
Drawn by	Name	Title	Size
Designed by		SINGLE LINE DIAGRAM OF 220/132kV OUTDOOR GIS & 33kV INDOOR SUBSTATION AT KUAKHIA	A1
Checked by		Drawing No: .....	Sheet Or 1/1
Approved by		Date: 07-11-2019	Scale: N. T. S.

Internal Reference Only